



DFD Architecture, LLC  
PO Box 182, Spring Lake, MI 49456

dfdarchitecture@gmail.com  
616 821 0936

Project Number 001-2017  
April 19, 2019

Contract Documents  
Masjid Sunnah Renovation  
2312 South Division Avenue  
Grand Rapids, MI 49507

Addenda No. 3A

NOTICE TO ALL PROSPECTIVE BIDDERS

This addenda is hereby made part of the Contract Documents

Sheets A101, Revision to Janitor and Entry Area, See attached plan

Sheet A111, Adjust the ceiling plan to the revised Sheet A101

Sheets P200, P201, Adjust the plumbing plans to revised Sheet A101

Sheet M200, M201, Adjust the mechanical plan to revised sheet A101


Sheet E201, adjust the electrical plan to revised Sheet A101.

Sheet E301, adjust lighting plan to revised Sheet A101


SHEET 1 - Addenda No. 3A

SHEET 2 - A101

End of Addenda No. 3A

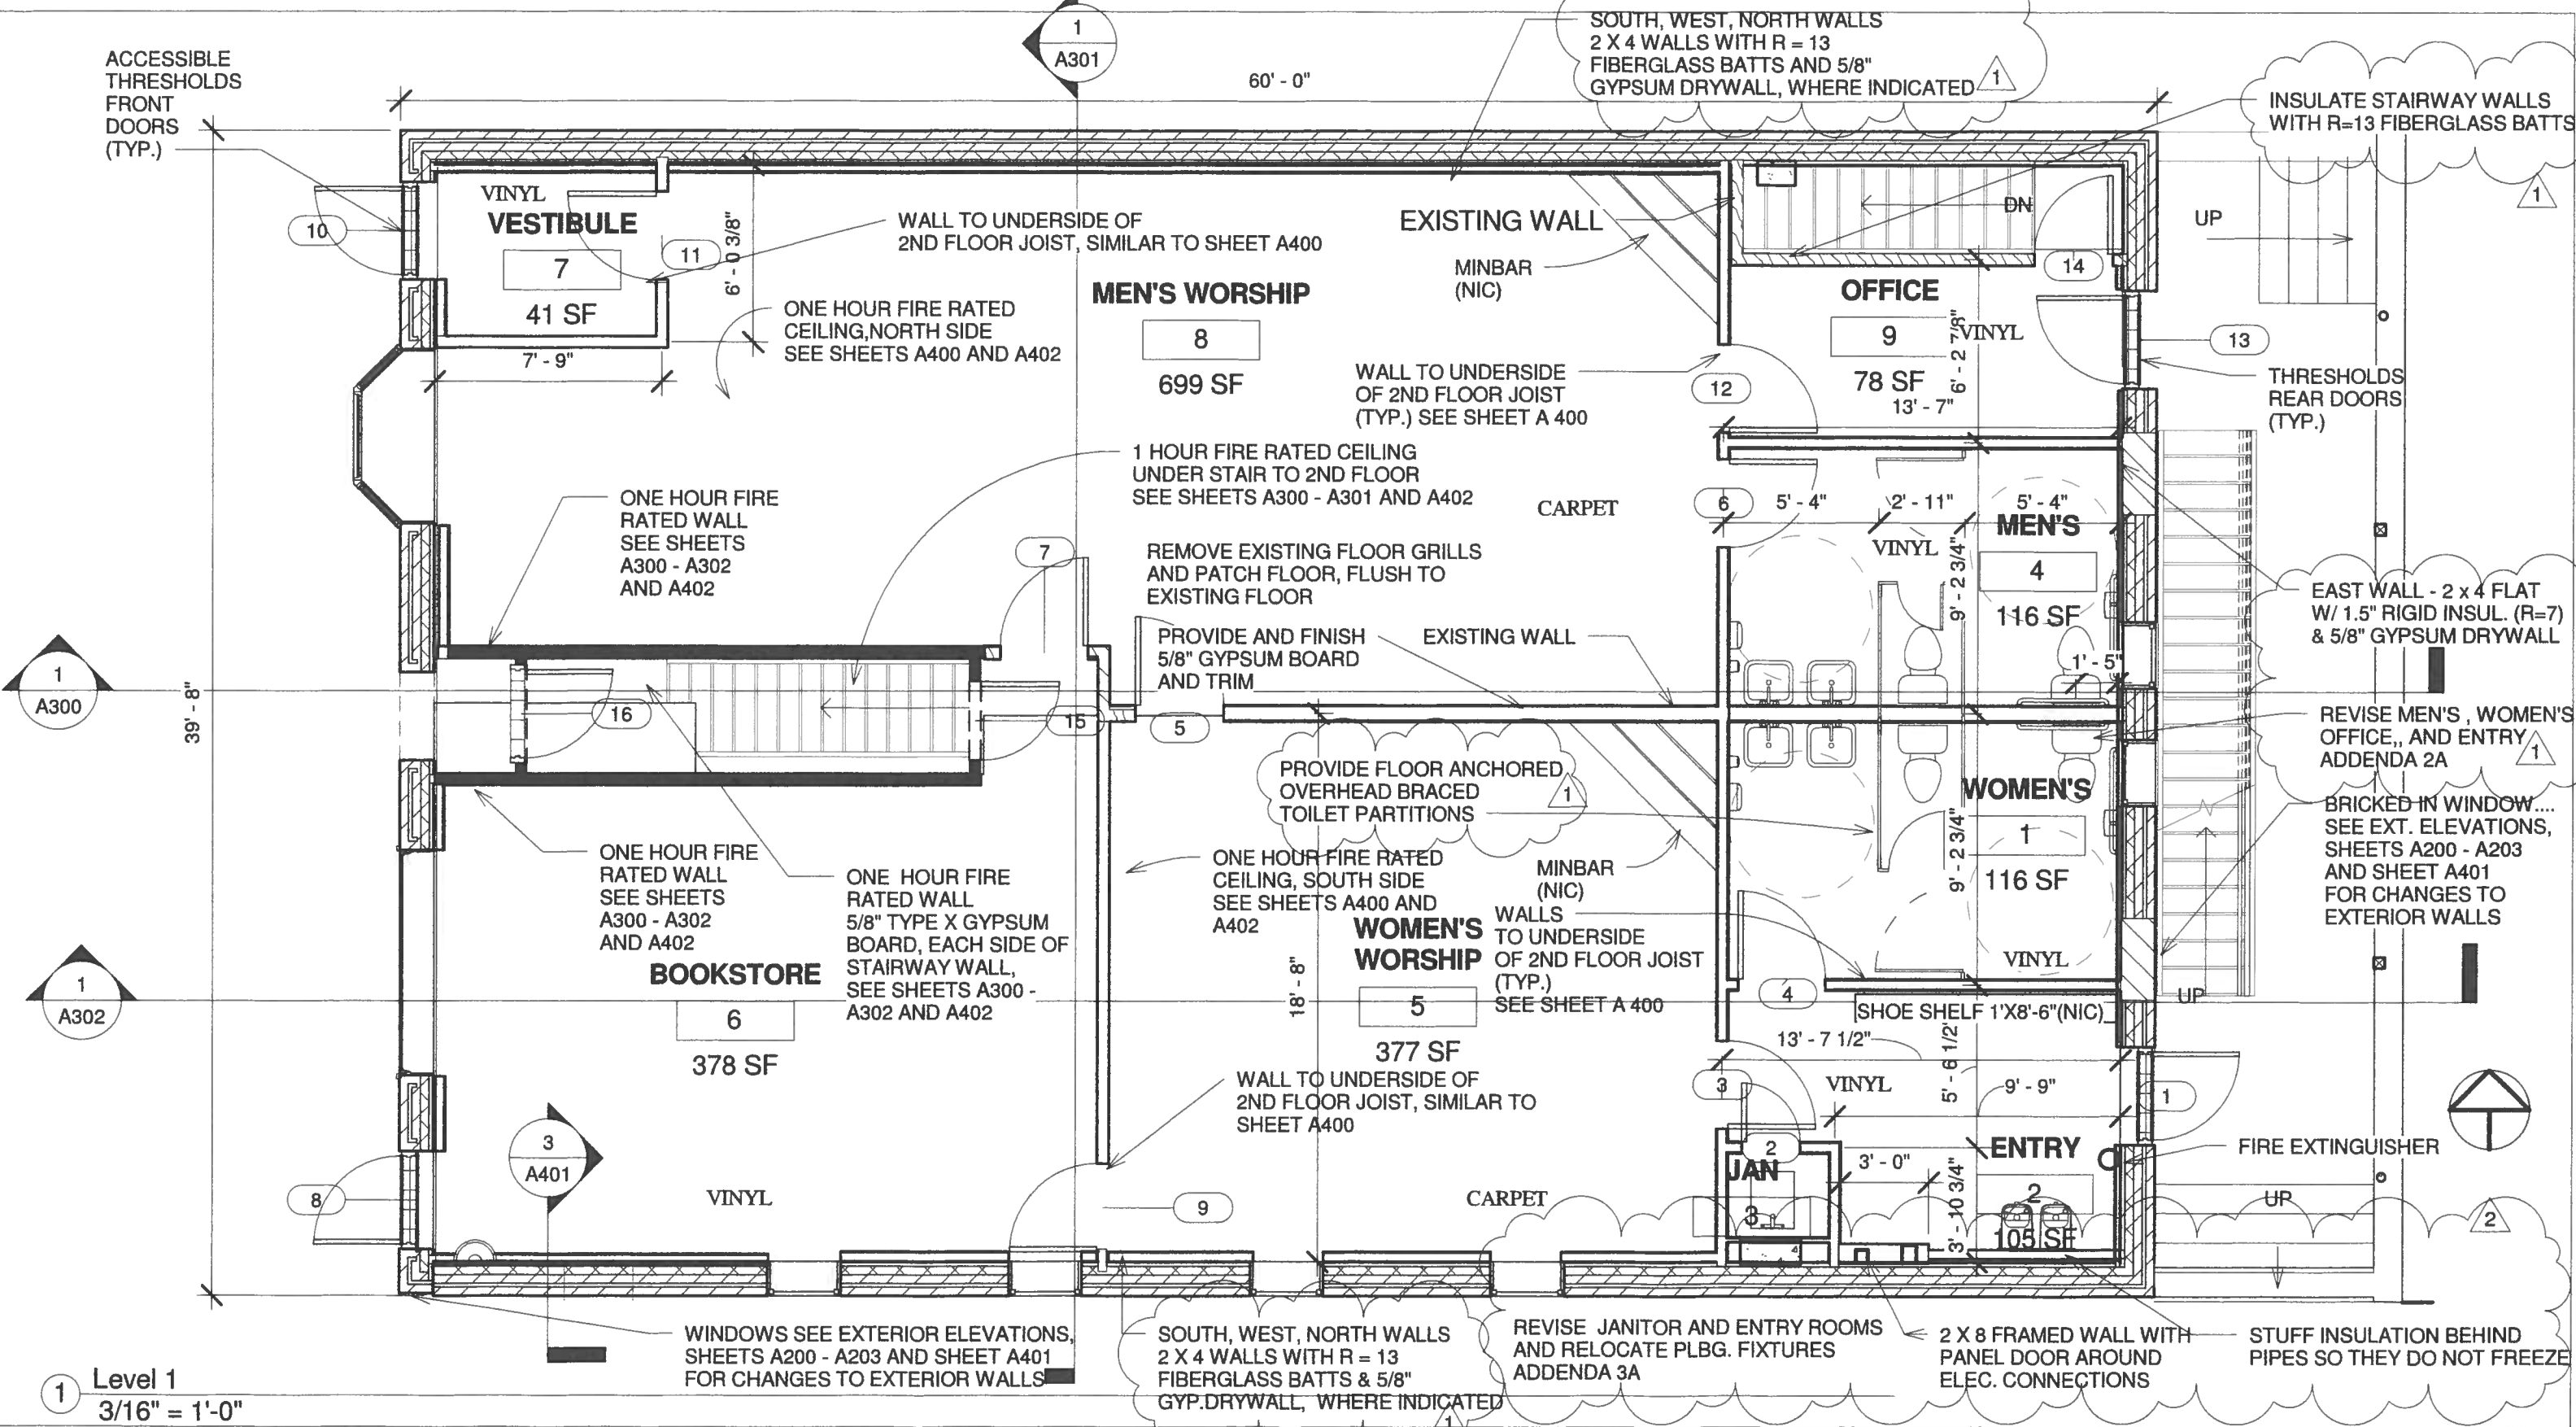

1 Level 1  
3/16" = 1'-0"

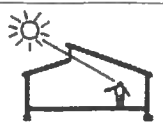

DFD Architecture, LLC

dfdarchitecture@gmail.com  
PO Box 182, Spring Lake, MI 49456  
616 821 0936

**Masjid Sunnah Renovation**  
2312 South Division,  
Grand Rapids, MI 49507

| No. | Description | Date      |
|-----|-------------|-----------|
| 1   | Addenda 2A  | 4/10/2019 |
| 2   | Addenda 3A  | 4/19/2019 |
|     |             |           |
|     |             |           |
|     |             |           |

**1st Floor Plan**

Project number 001-2017  
Date 6/11/2018  
Drawn by David Dye  
Checked by f

**A101**

Scale 3/16" = 1'-0"